



LEGEND

- HUNTER PRO-06-NSI-PRSSO SERIES POP UP SPRAY HEADS WITH HUNTER MSBN-50H STREAM BUBBLER NOZZLES. (TWO PER TREE)
SEE INSTALLATION NOTE #13 REGARDING TREE BUBBLER LATERAL PIPE
- ▨ NETAFIM TECHLINE CV SERIES DRIP TUBE IN SHRUB BED INSTALLED AT 2" DEPTH
SEE INSTALLATION NOTE #16 REGARDING DRIP TUBE LAYOUT IN SHRUB BEDS.
- ▤ NETAFIM TECHLINE CV SERIES DRIP TUBE IN NARROW TURF AREAS INSTALLED AT 4" DEPTH
SEE INSTALLATION NOTE #17 REGARDING DRIP TUBE LAYOUT IN TURF.
- ⊕ HUNTER 1" ICV SERIES ELECTRIC REMOTE CONTROL "MASTER" VALVE
- ⊕ HUNTER PC2 SERIES ELECTRIC REMOTE CONTROL VALVE WITH 25 PSI REGULATOR AND 150 MESH FILTER
- ⊕ NETAFIM LVCZ SERIES DRIP VALVE ASSEMBLY WITH 42 PSI REGULATOR AND 140 MESH FILTER
USE MODEL LVCZ98010075-LF FOR DRIP ZONES WITH 25 TO 4 GPM FLOW RATE
USE MODEL LVCZ98010075-HF FOR DRIP ZONES WITH 5 TO 12 GPM FLOW RATE
USE MODEL LVCZ-150 FOR DRIP ZONES WITH 13 TO 35 GPM FLOW RATE
- IRRIGATION WATER METER AND TAP, SIZE AS NOTED ON THE PLAN
- ⊕ 3/4" WILKINS 950 SERIES D.C.A. INSTALLED PER CITY CODE, WITH SAME SIZE WILKINS 850 SERIES BRONZE BALL VALVE AND WILKINS YB SERIES BRONZE MVE FILTER WITH 20 MESH STAINLESS STEEL SCREEN
- ⊕ HUNTER IC-600M SERIES AUTOMATIC CONTROLLER WITH WIRELESS "SOLAR SYNC" ET SENSOR
LOCATE SENSOR AS FIELD DIRECTED BY THE LANDSCAPE ARCHITECT
- CLASS 200 PVC MAINLINE PIPE
- CLASS 200 (EXCEPT 1/2 INCH #815) PVC LATERAL PIPE
- ONE 3" CLASS 200 SLEEVE PIPE UNLESS NOTED OTHERWISE
- ONE 3" AND ONE 2" CLASS 200 SLEEVE PIPES UNLESS NOTED OTHERWISE
- ONE 1 1/2" CLASS 200 PVC CONDUIT WITH LONG RADIUS "SWEEP" FITTINGS

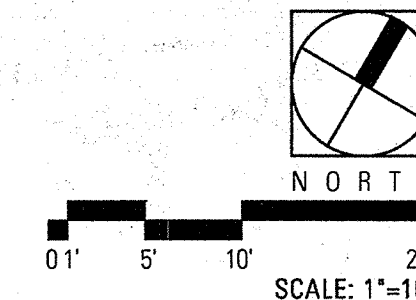

MATCHLINE: REF. L-9

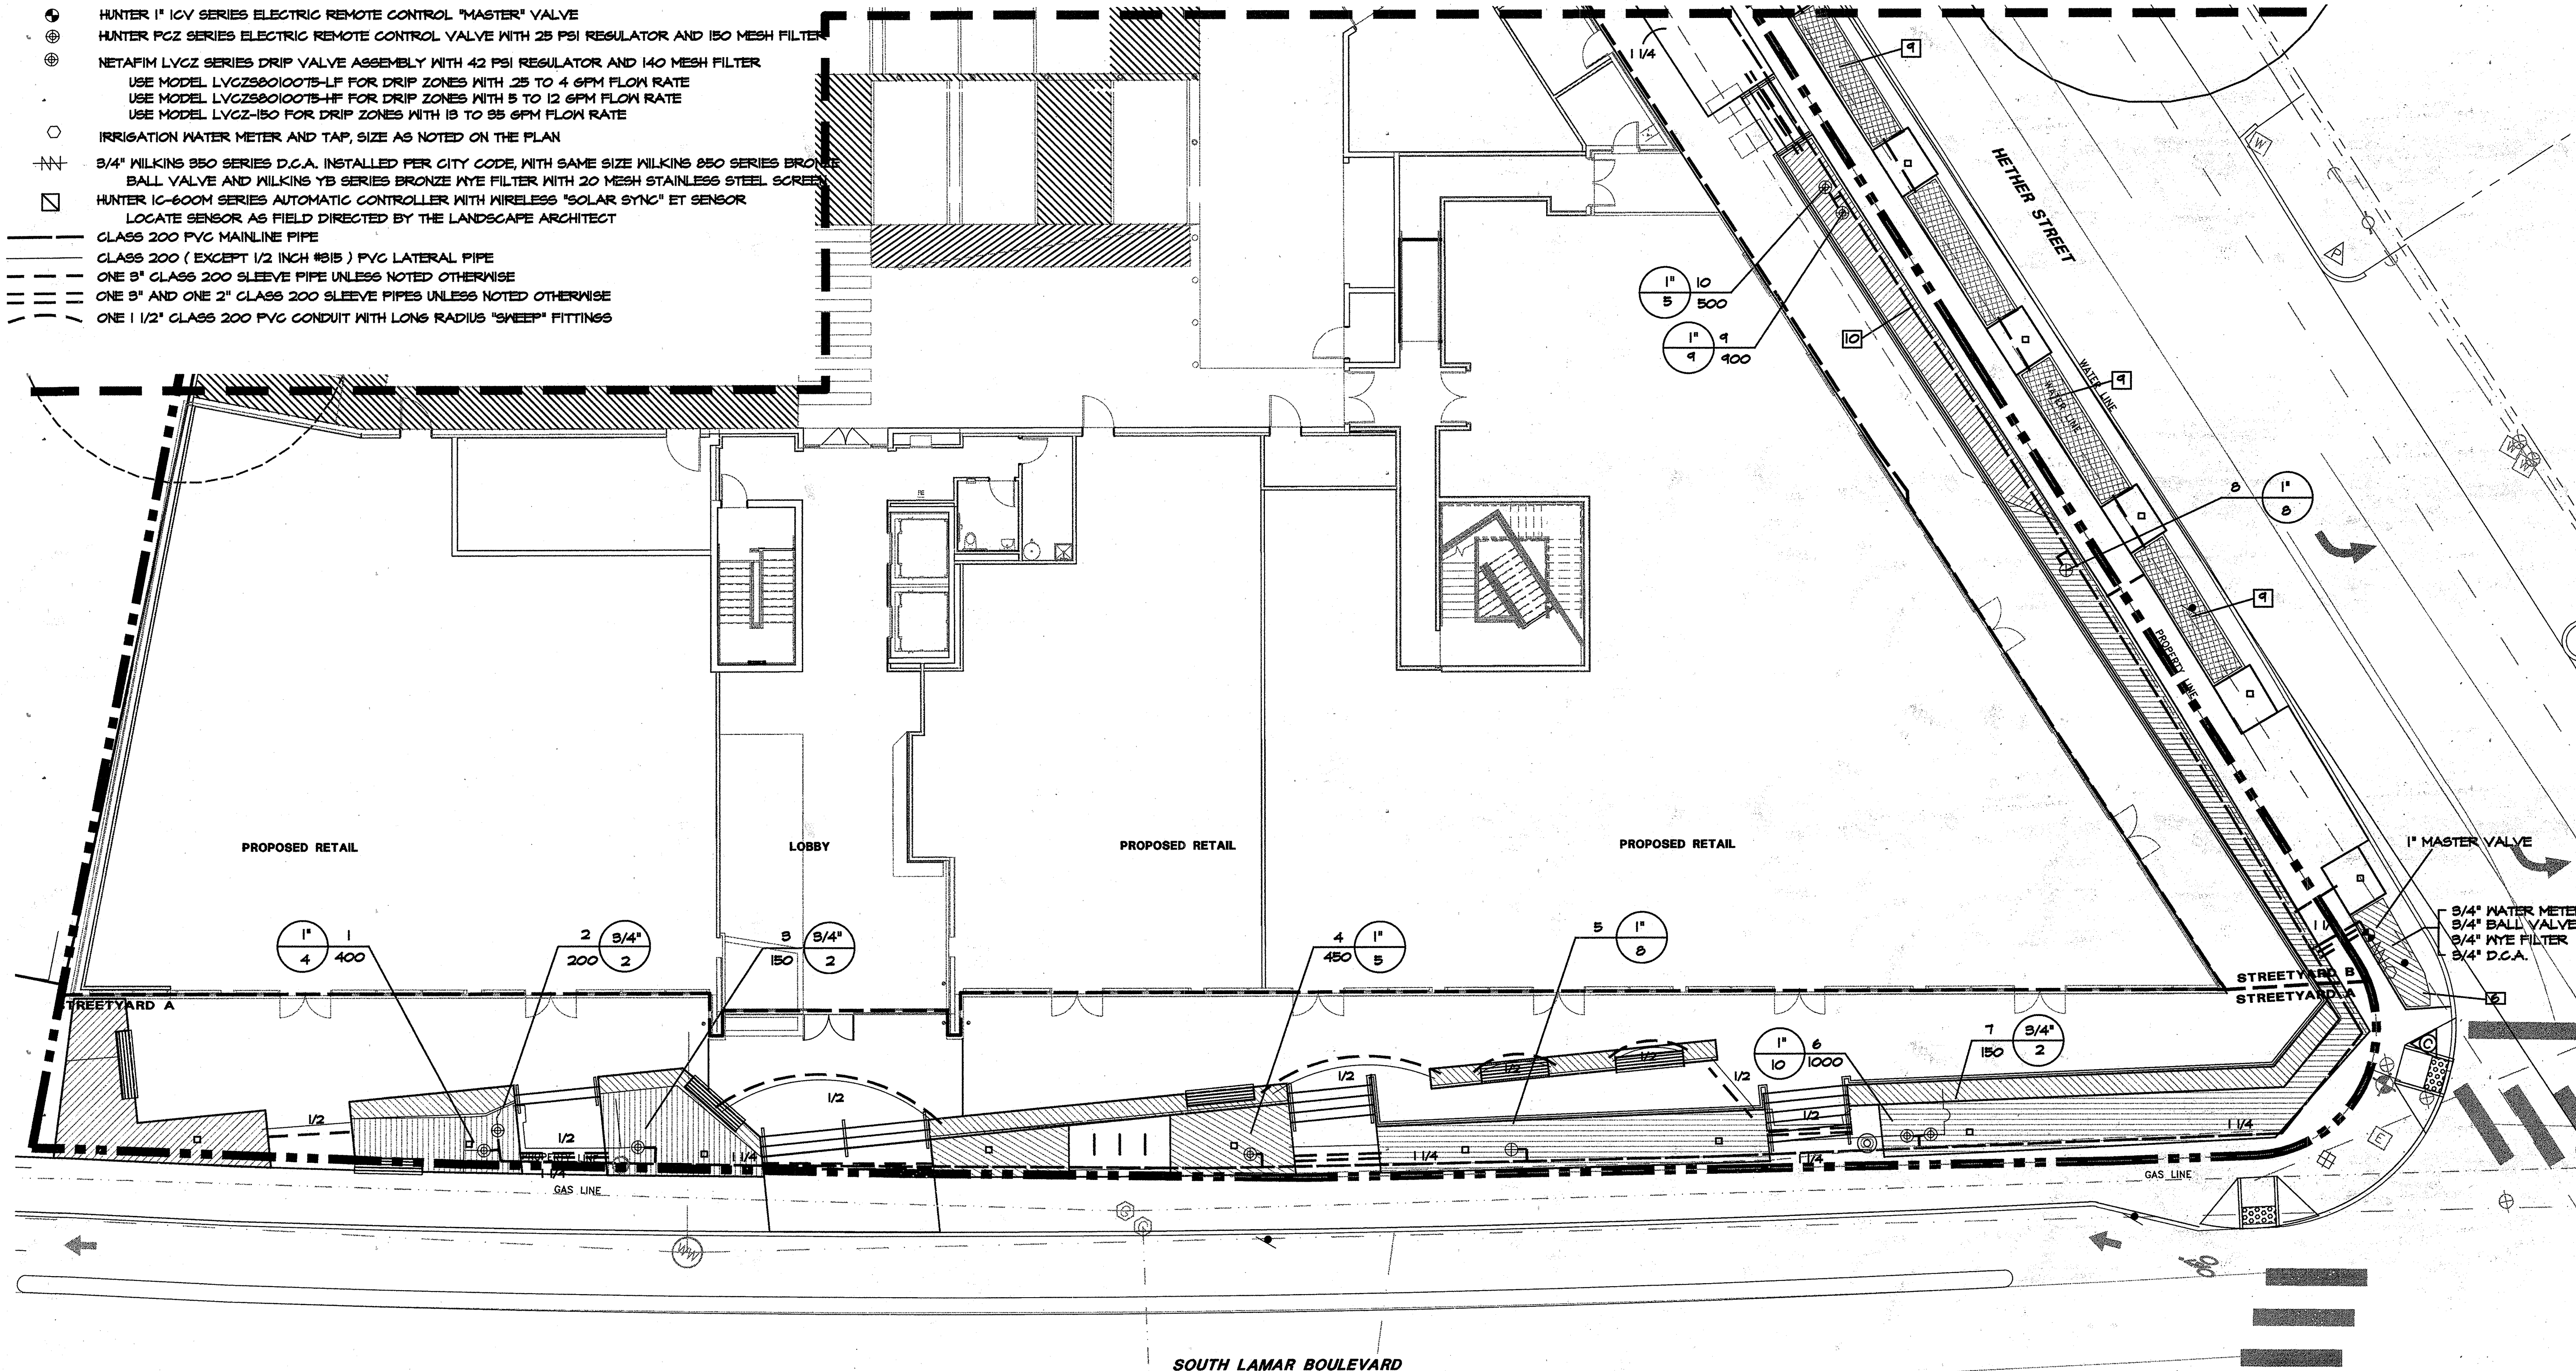

FOR REVIEW ONLY
Not for regulatory approval,
permitting or construction.
**FOR
PERMITTING
ONLY**
David Elliott Doefer II TX# 2586

Landscape Architects • Planners
1705 Guadalupe Street, Suite 500
Austin, Texas 78701
(512) 327-1011 Fax: (512) 327-0488

Austin • Dallas • Fort Lauderdale
Fort Worth • Houston • San Antonio • Tulsa

Project:
**2010 SOUTH
LAMAR OFFICE**

SITE
DEVELOPMENT
PERMIT

AUSTIN, TEXAS

Project Number:
A15412

Designed: JP

Drawn: JP

Reviewed: JP

Date Issued:
May 24, 2017


Revisions:

Sheet Title:
**IRRIGATION
PLAN**


Sheet Number:

L-10

SP-2016-0196C

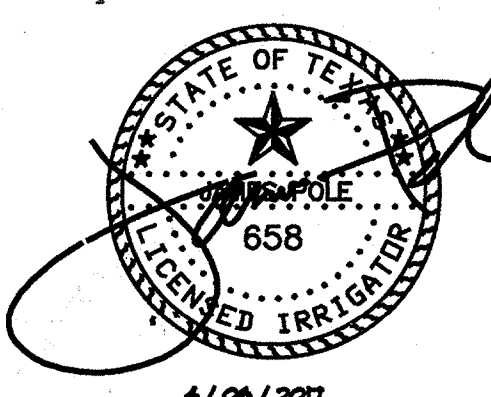

4 / 06 / 2017

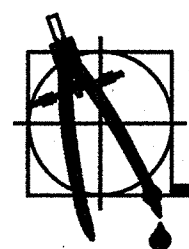

James Pole
IRRIGATION CONSULTANTS

IRRIGATION DESIGN, CONSULTING, AND
LANDSCAPE WATER MANAGEMENT
TEXAS LLC, 8888
100 N. LOCUST ST., SUITE B
DENTON, TEXAS 76201
PHONE: 469.248.2884
FAX: 469.282.3478
james@jamespoleirrigation.com



IRRIGATION IN TEXAS IS REGULATED BY
THE TEXAS COMMISSION ON ENVIRONMENTAL
QUALITY (TCEQ) (140-TS) P.O. BOX 18091
TCEQ'S WEB SITE IS: WWW.TCEQ.STATE.TX.US

FOR CITY USE ONLY:

SITE PLAN APPROVAL Sheet 30 of 38
FILE NUMBER: SP-2016-0196C APPLICATION DATE: April 22, 2016
APPROVED BY COMMISSIONER ON 4/27/17 UNDER SECTION 112 OF
CHAPTER 25 OF THE CITY OF AUSTIN CODE. Donna Gahan
EXPIRATION DATE (25-6-61.12C) CASE MANAGER
PROJECT EXPIRATION DATE (ORD 4070006-4) 7/29/2017 DDG
Director, Development Services Department
RELEASED FOR GENERAL COMPLIANCE: _____ SONDG: LS
Rev. 1 _____ Correction 1 _____
Rev. 2 _____ Correction 2 _____
Rev. 3 _____ Correction 3 _____
FINAL PLAN MUST BE RECORDED BY THE PROJECT EXPIRATION DATE. IF
APPLICABLE, SUBSEQUENT SITE PLANS MUST DO NOT COMPLY WITH THE
CODE CURRENTLY AT THE TIME OF FILING AND ALL REQUIRED BUILDING
PERMITS AND/OR A NOTICE OF CONSTRUCTION (IF A BUILDING PERMIT IS
NOT REQUIRED), MUST ALSO BE APPROVED PRIOR TO THE PROJECT
EXPIRATION DATE.